



ARCHITECTS
700 W. VIRGINIA STREET, SUITE 604
MILWAUKEE, WI 53204
414.277.8000
MADISENMAHER.COM

A NEW PROJECT FOR:

BADGERLAND DISPOSAL

PUTMAN PARKWAY
MILTON, WI 53563



CLIENT:
HUGHES REYNOLDS GROUP LLC.
JASON HUGHES
#608.358.0984
DUSTIN REYNOLDS
#414.803.6866


Drawings and Specifications as instruments of service are the property of Madisen Maher Architects, whether the work for which they are made be executed or not and are not to be used or copied on other work except by written agreement with Madisen Maher Architects.

DATE	ISSUED SET
02/26/19	PLAN COMMISSION


Project Number	17-064
Start Date	1/17/17
Drawn By	RRT
Checked By	RRT
Scale	1/8" = 1'-0"

FIRST FLOOR
PLAN
BUILDING A

A1.01A

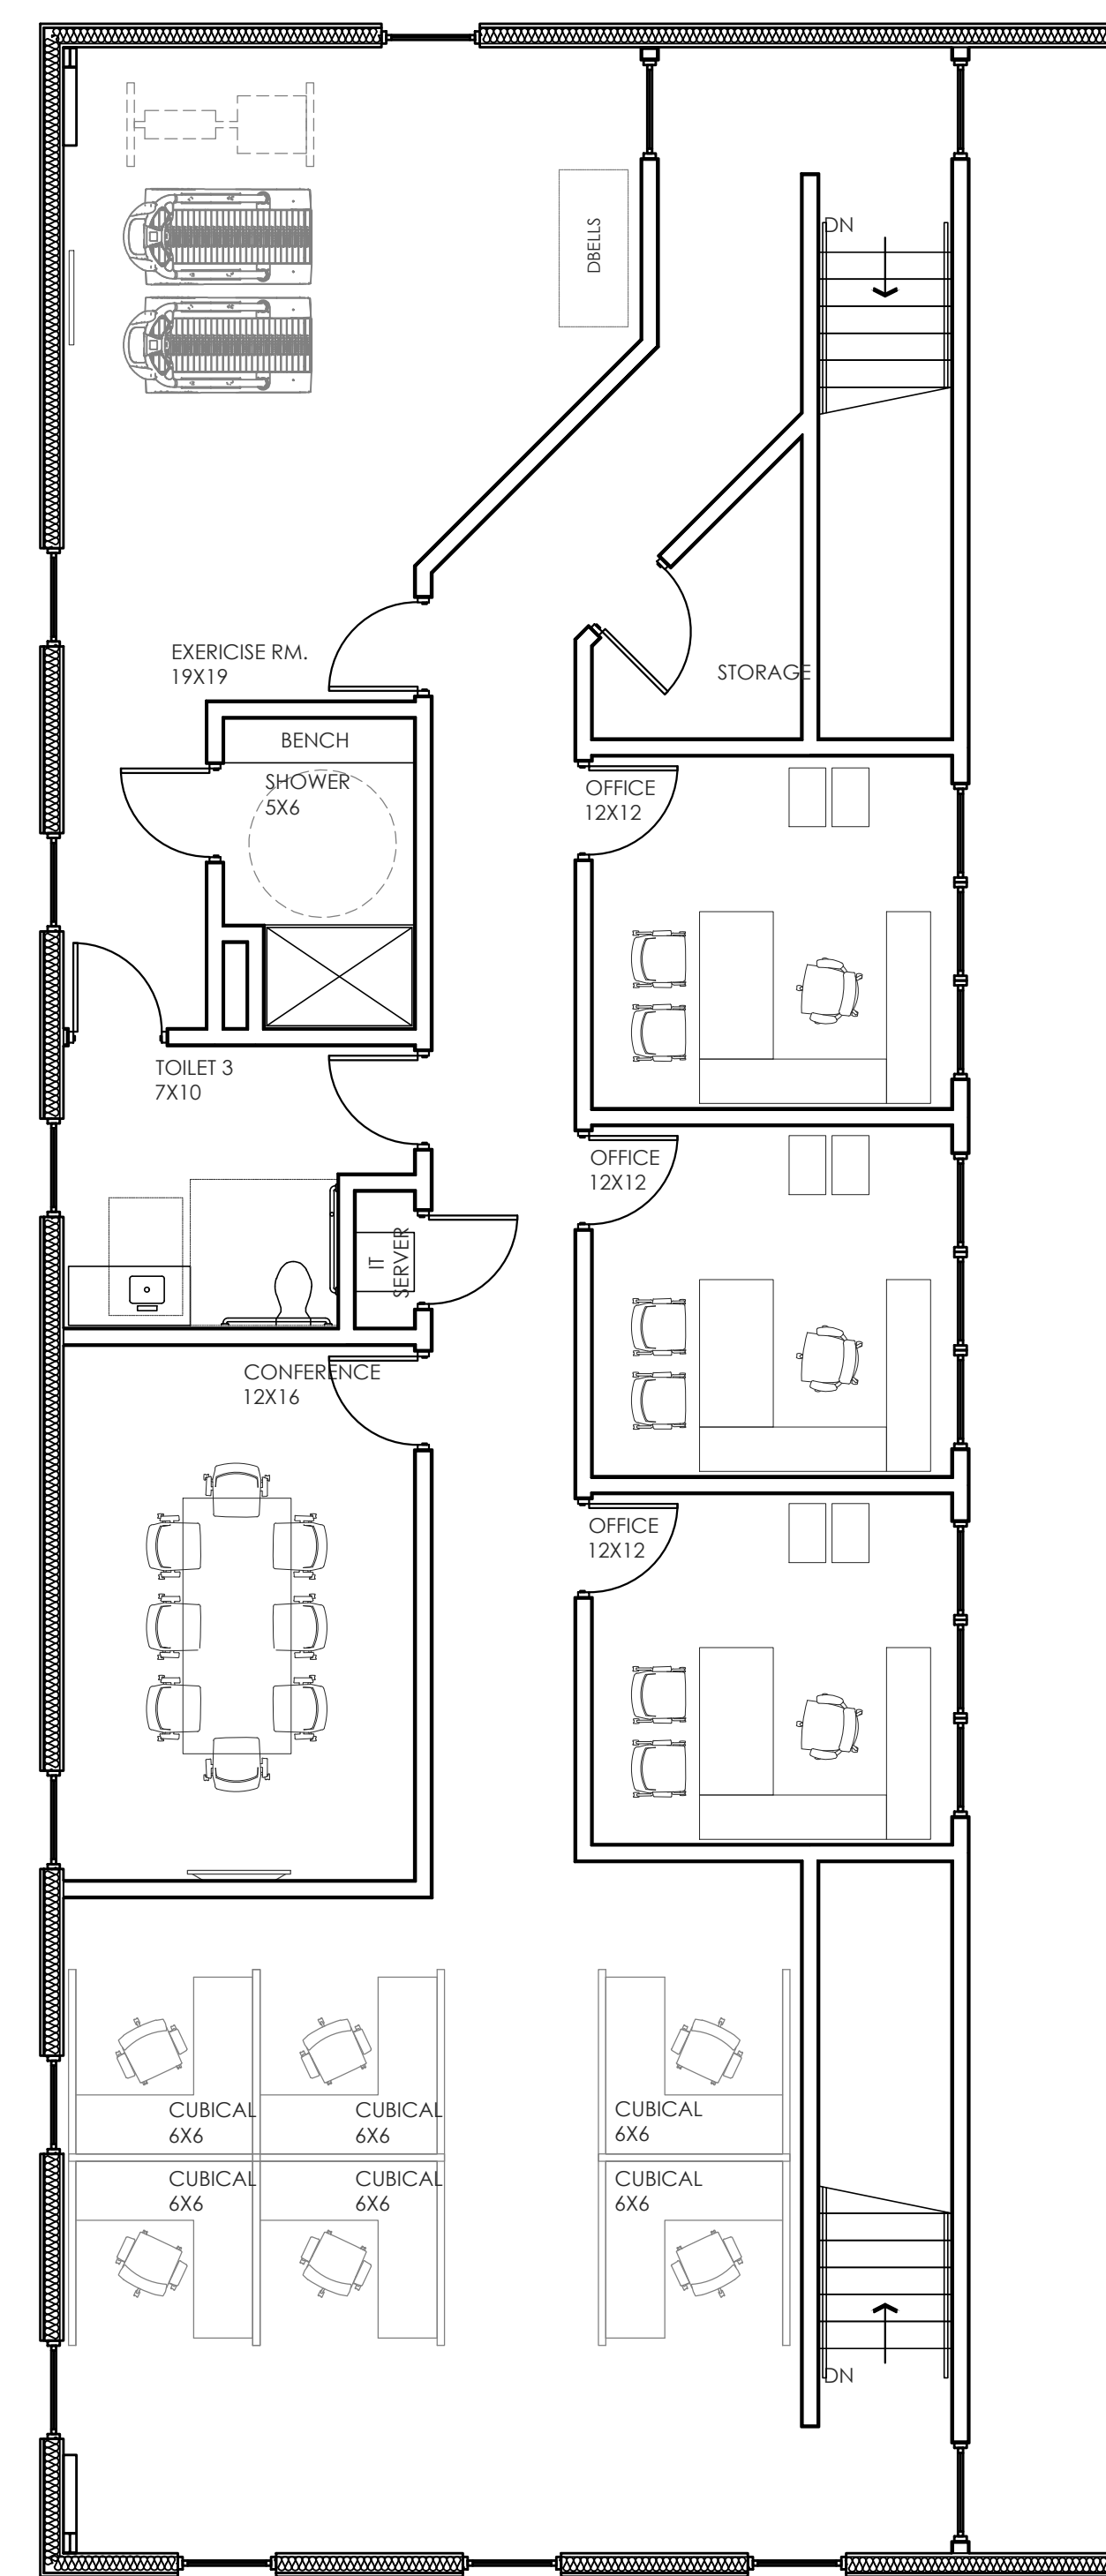

MEZZ. PLAN 1/8" = 1'-0"
MEZZ.- 2,728 sqft.

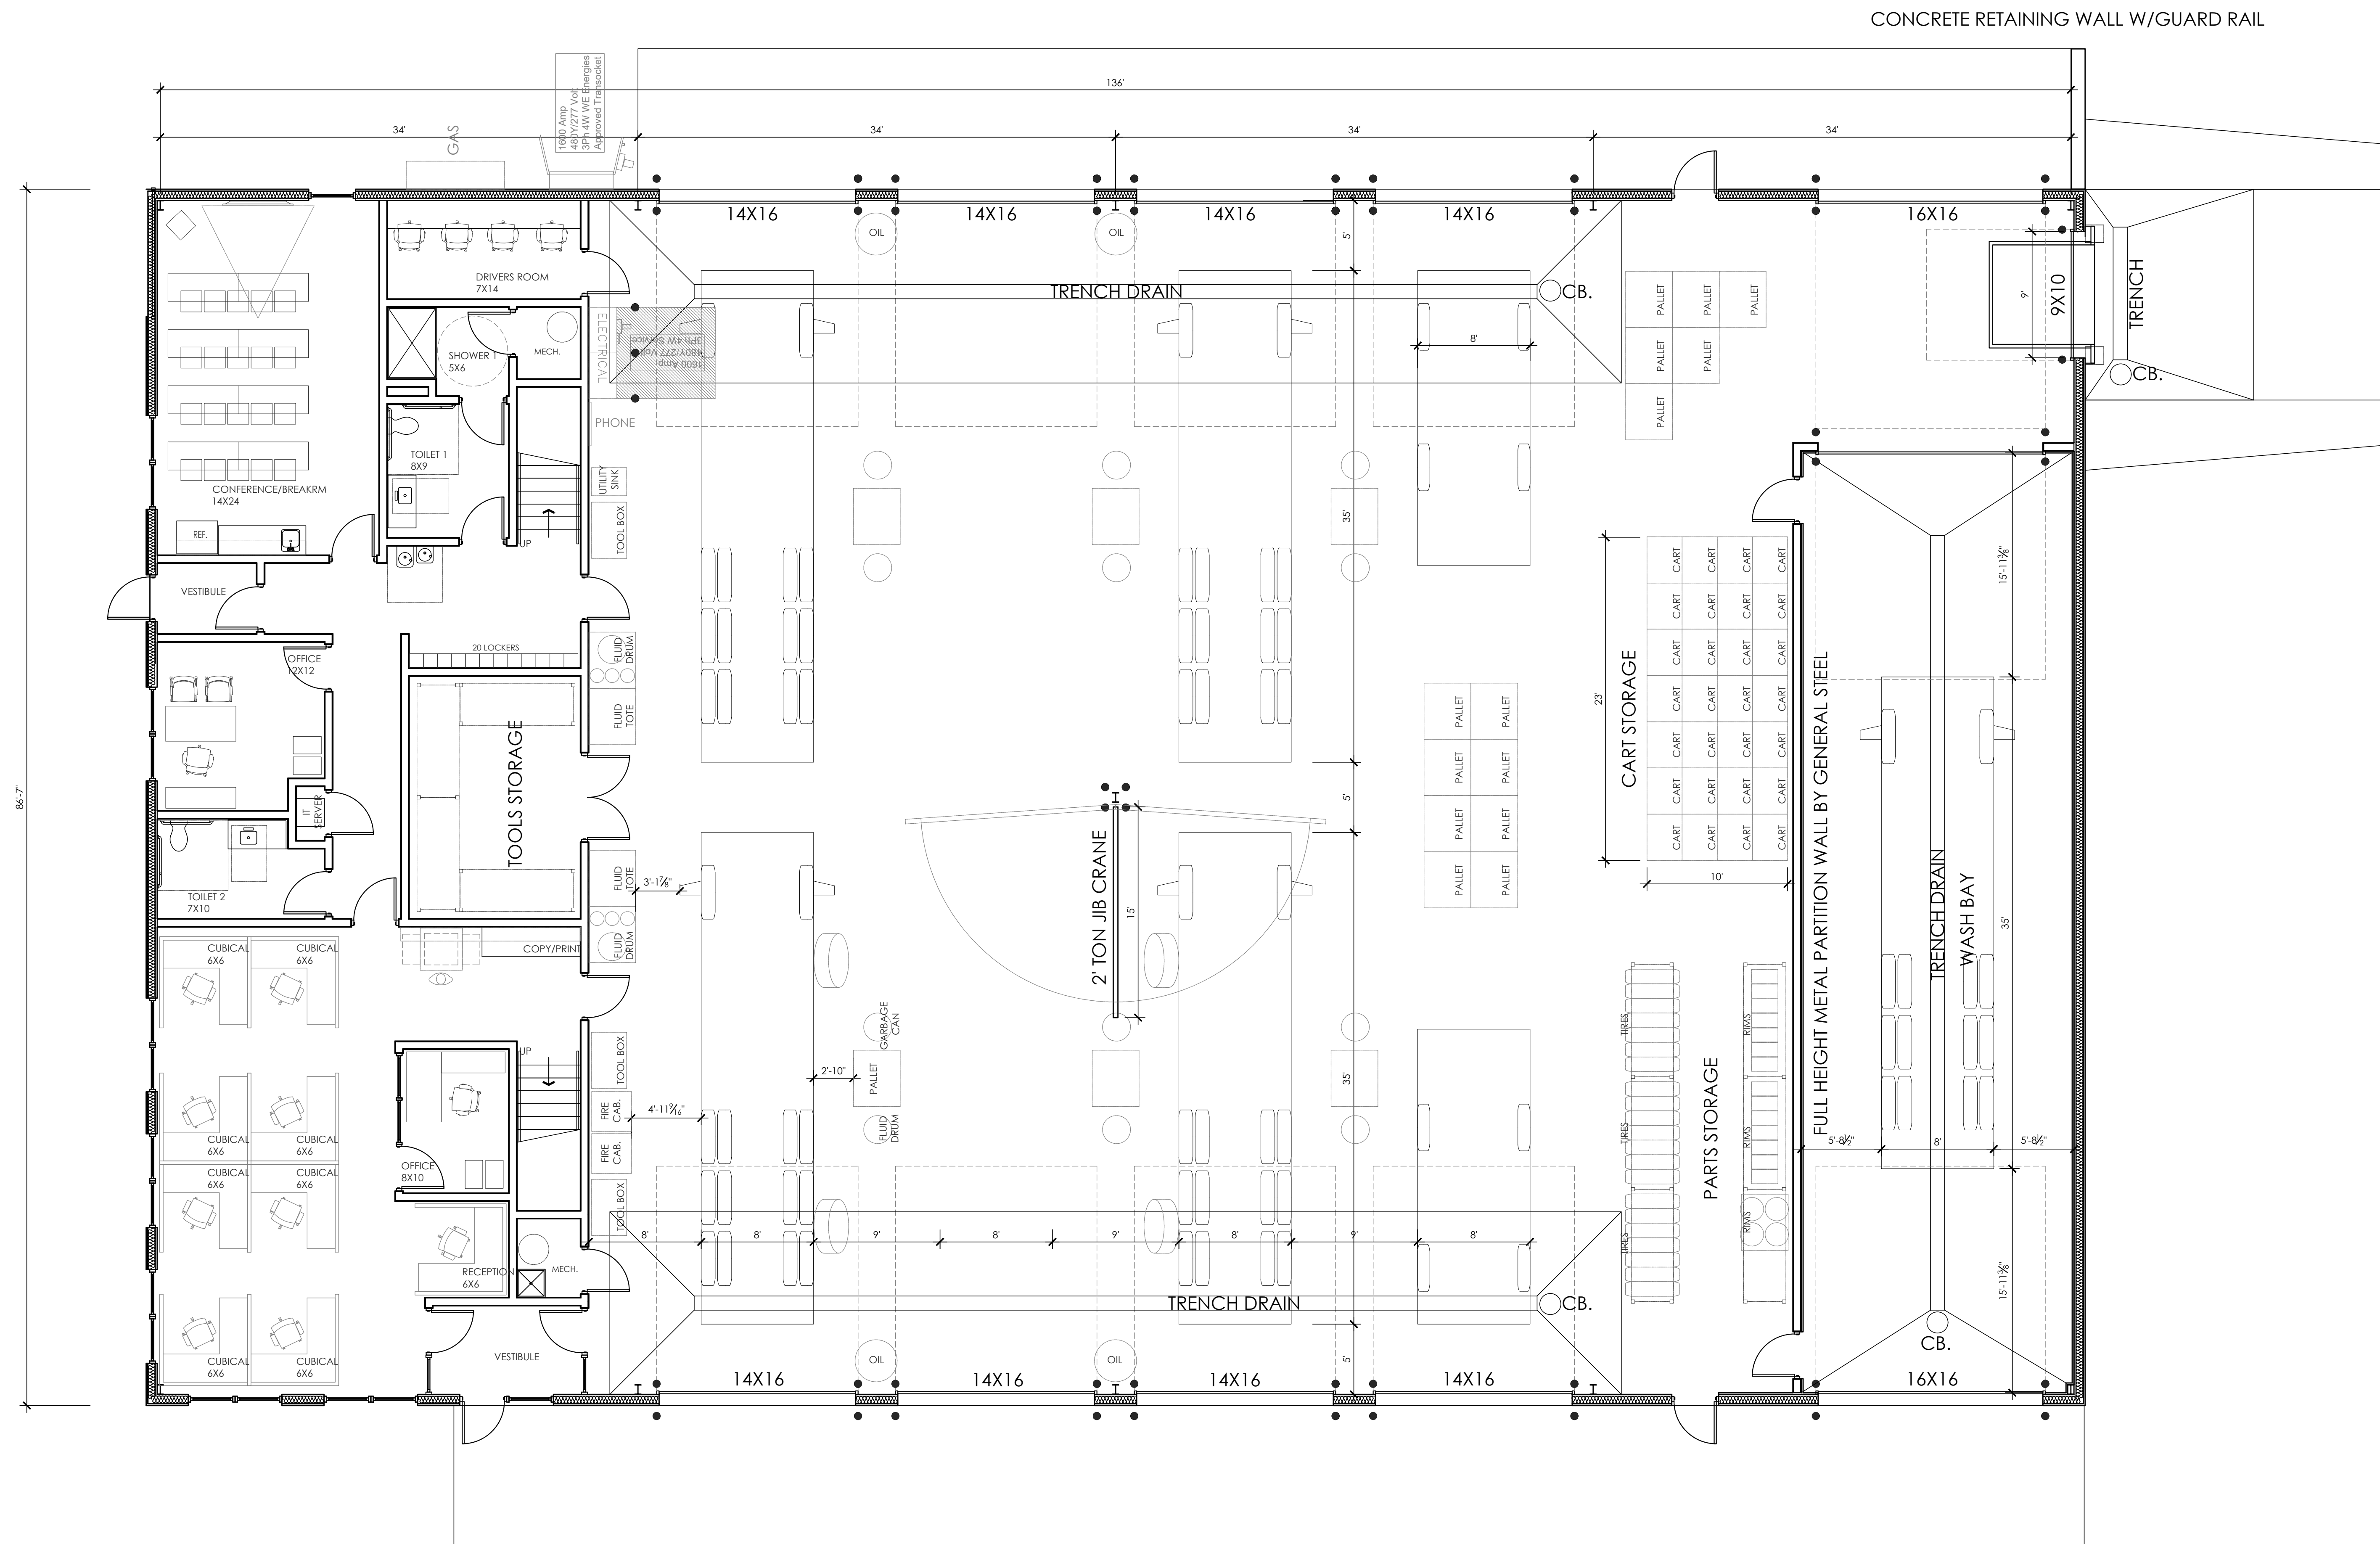

FIRST FLOOR PLAN 1/8" = 1'-0"
FIRST FLOOR - 11,995 sqft.