



ARCHITECTS
 700 W. VIRGINIA STREET, SUITE 604
 MILWAUKEE, WI 53204
 414.277.8000
 MADISENMAHER.COM

A NEW PROJECT FOR:
BADGERLAND DISPOSAL
 PUTMAN PARKWAY
 MILTON, WI 53563



CLIENT:
 HUGHES REYNOLDS GROUP LLC.
 JASON HUGHES
 #608.358.0984
 DUSTIN REYNOLDS
 #414.803.6866


Drawings and Specifications as instruments of service are the property of Madisen Maher Architects, whether the work for which they are made be executed or not and are not to be used or copied on other work, except by written agreement with Madisen Maher Architects.

DATE	ISSUED SET
02/11/19	SITE PLAN

Project Number	17-064
Start Date	1/17/17
Drawn By	RRT
Checked By	RRT
Scale	1" = 60'-0"

PRELIMINARY
 ARCH.
 SITE PLAN
 13.8 ACRES

A0.04

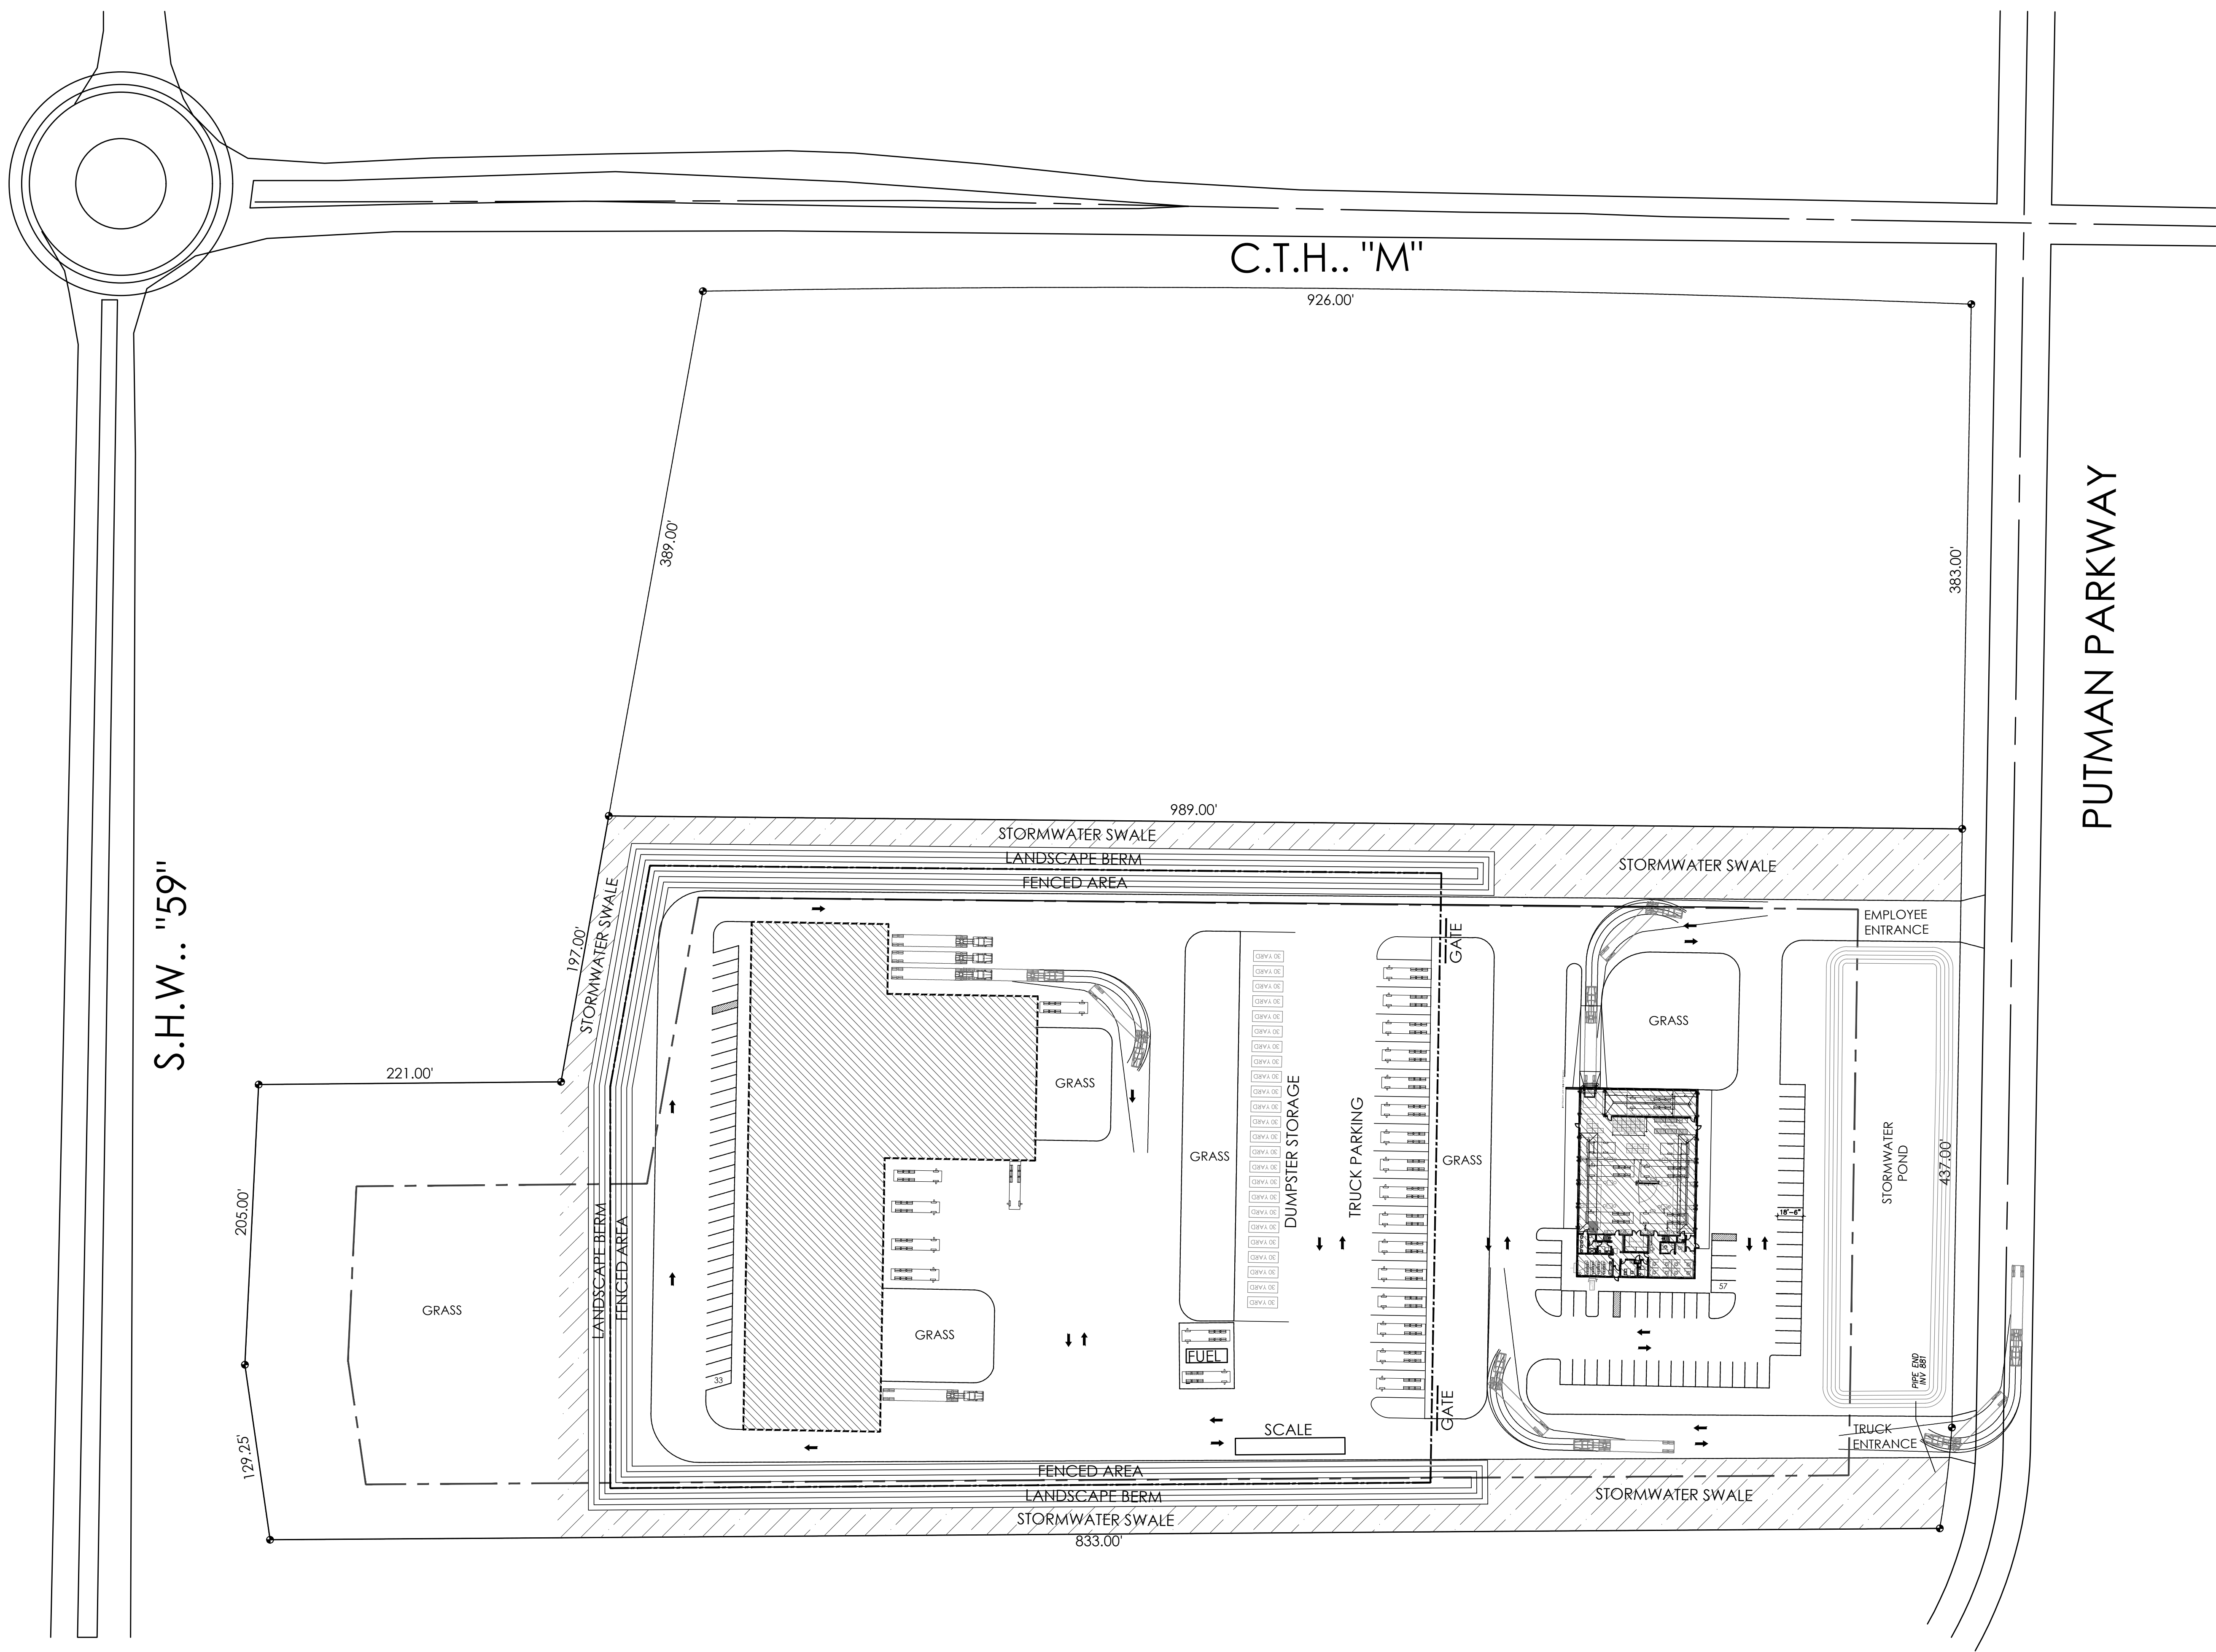

⊖ ARCH. SITE PLAN 1" = 60'-0"